


1 WALL SECTION
 A-300 | A-311 | 1'-4" 8" 0' 1'-4" 2'-8"
 SCALE: 3/4" = 1'-0"



2 WALL SECTION
 A-300 | A-311 | 1'-4" 8" 0' 1'-4" 2'-8"
 SCALE: 3/4" = 1'-0"

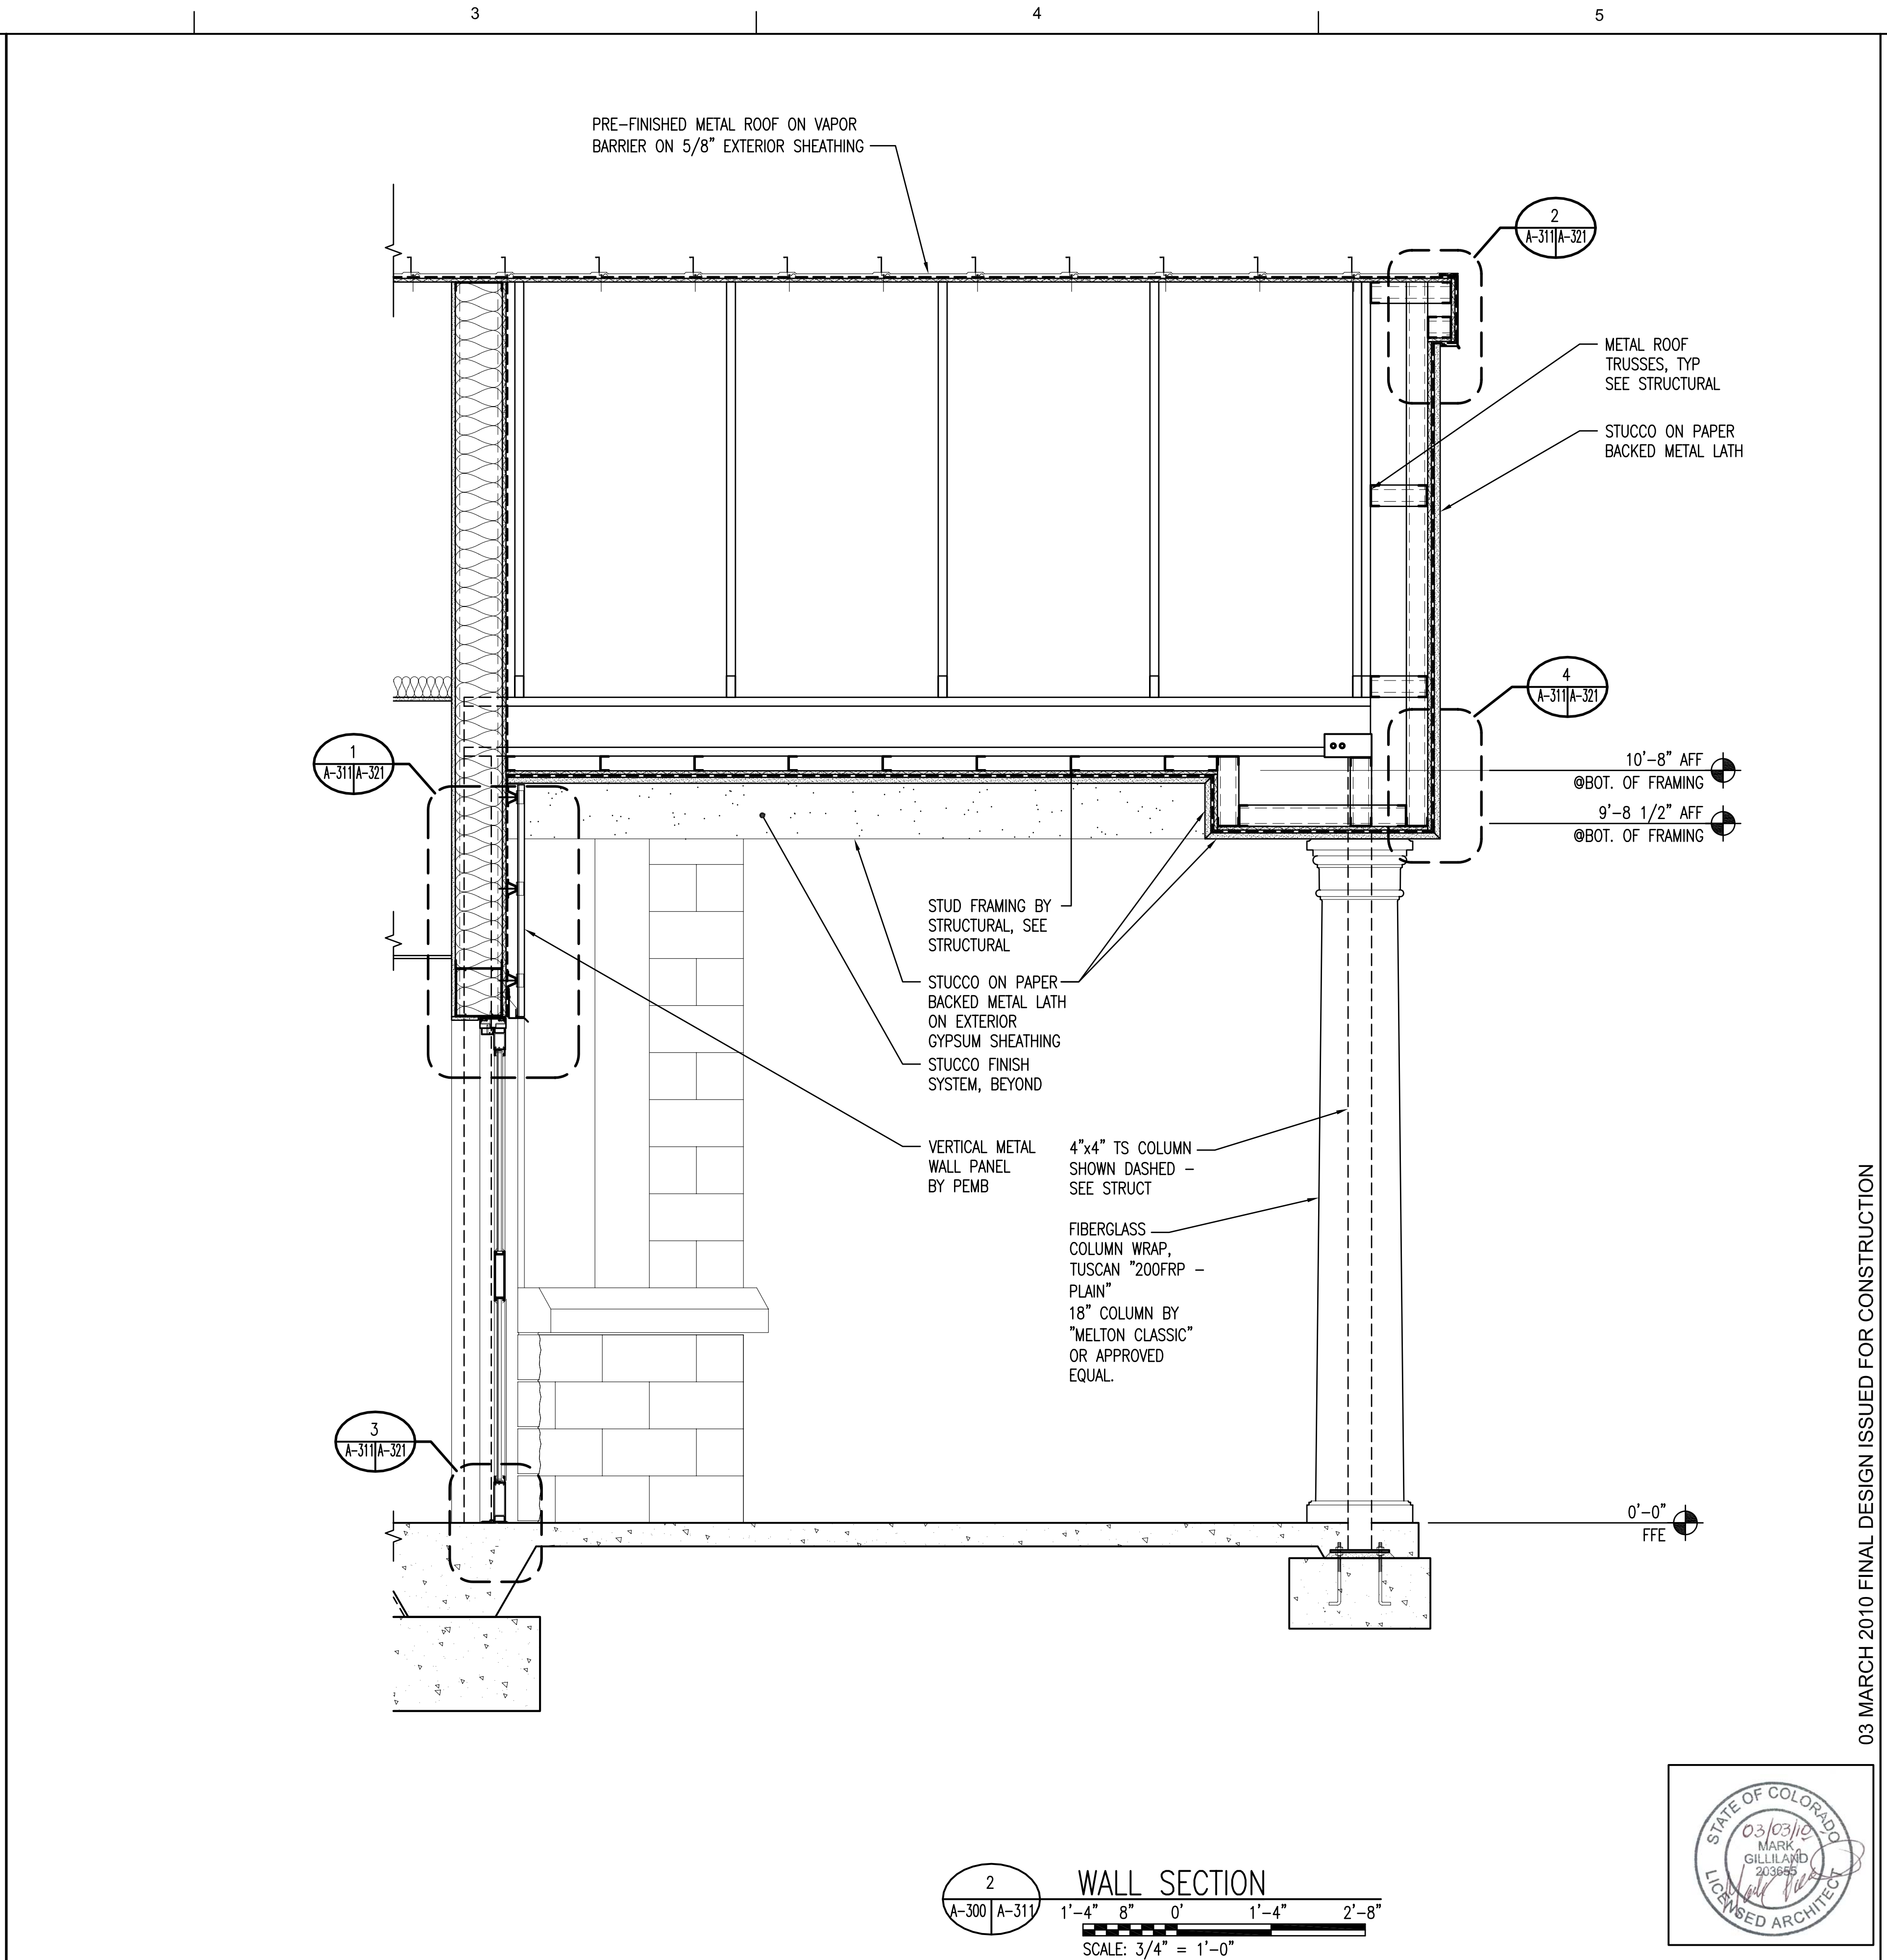

MARK	DESCRIPTION	DATE	APPR.
A	65% PRE-FINAL DESIGN	7/29/09	
B	100% FINAL DESIGN	9/18/09	

DESIGNED BY: U.S. ARMY CORPS OF ENGINEERS HUNTSVILLE CENTER	DESIGNED BY: FHM SUBMITTED BY: HM BK	DATE: 03/03/10	CONTRACT NO. 1: W912DY-09-2-003	FILE NUMBER: AS NOTED
STOA ARCHITECTS 121 EAST GOVERNMENT STREET PENSACOLA, FL 32502	STOA ARCHITECTS PLOT SCALE: PLOT DATE: AS NOTED	FILE NAME: ANSID		

03 MARCH 2010 FINAL DESIGN ISSUED FOR CONSTRUCTION

15TH STREET FIRE STATION
 FORT STEWART, GEORGIA

WALL SECTIONS



SHEET IDENTIFICATION
A-311
 SHEET 46 OF 117