


GENERAL NOTES


1. PROVIDE INTEGRATED SPD WITH CIRCUIT BREAKER DISCONNECT TO SATISFY UL LIGHTNING PROTECTION REQUIREMENTS. COORDINATE CIRCUIT BREAKER RATING WITH SPD REQUIREMENTS.
2. COORDINATE LOCATION OF EQUIPMENT WITH OTHER TRADES.
3. PROVIDE MOTOR RATED SWITCH OR DISCONNECT SWITCH FOR ALL MOTORS, FAN COIL UNITS, HEATERS, CONDENSINGS, PUMPS, AND OTHER ASSOCIATED MECHANICAL EQUIPMENT AS INDICATED.

SHEET NOTES


- ① INSTALL PANELBOARD AND ALL ASSOCIATED FEEDER AND BRANCH CIRCUITS AS INDICATED ON PANELBOARD SCHEDULES AS SHOWN.
- ② CONNECT ELECTRICAL POWER SOURCE TO FCU AS REQUIRED. COORDINATE WITH MECHANICAL AND MANUFACTURER RECOMMENDATIONS.
- ③ CONNECT ELECTRICAL POWER SOURCE TO FAN/LIGHT AS REQUIRED. COORDINATE WITH MECHANICAL MANUFACTURER RECOMMENDATIONS.
- ④ CONNECT ELECTRICAL POWER SOURCE TO HEAT PUMP AS REQUIRED. COORDINATE WITH MECHANICAL MANUFACTURER RECOMMENDATIONS.

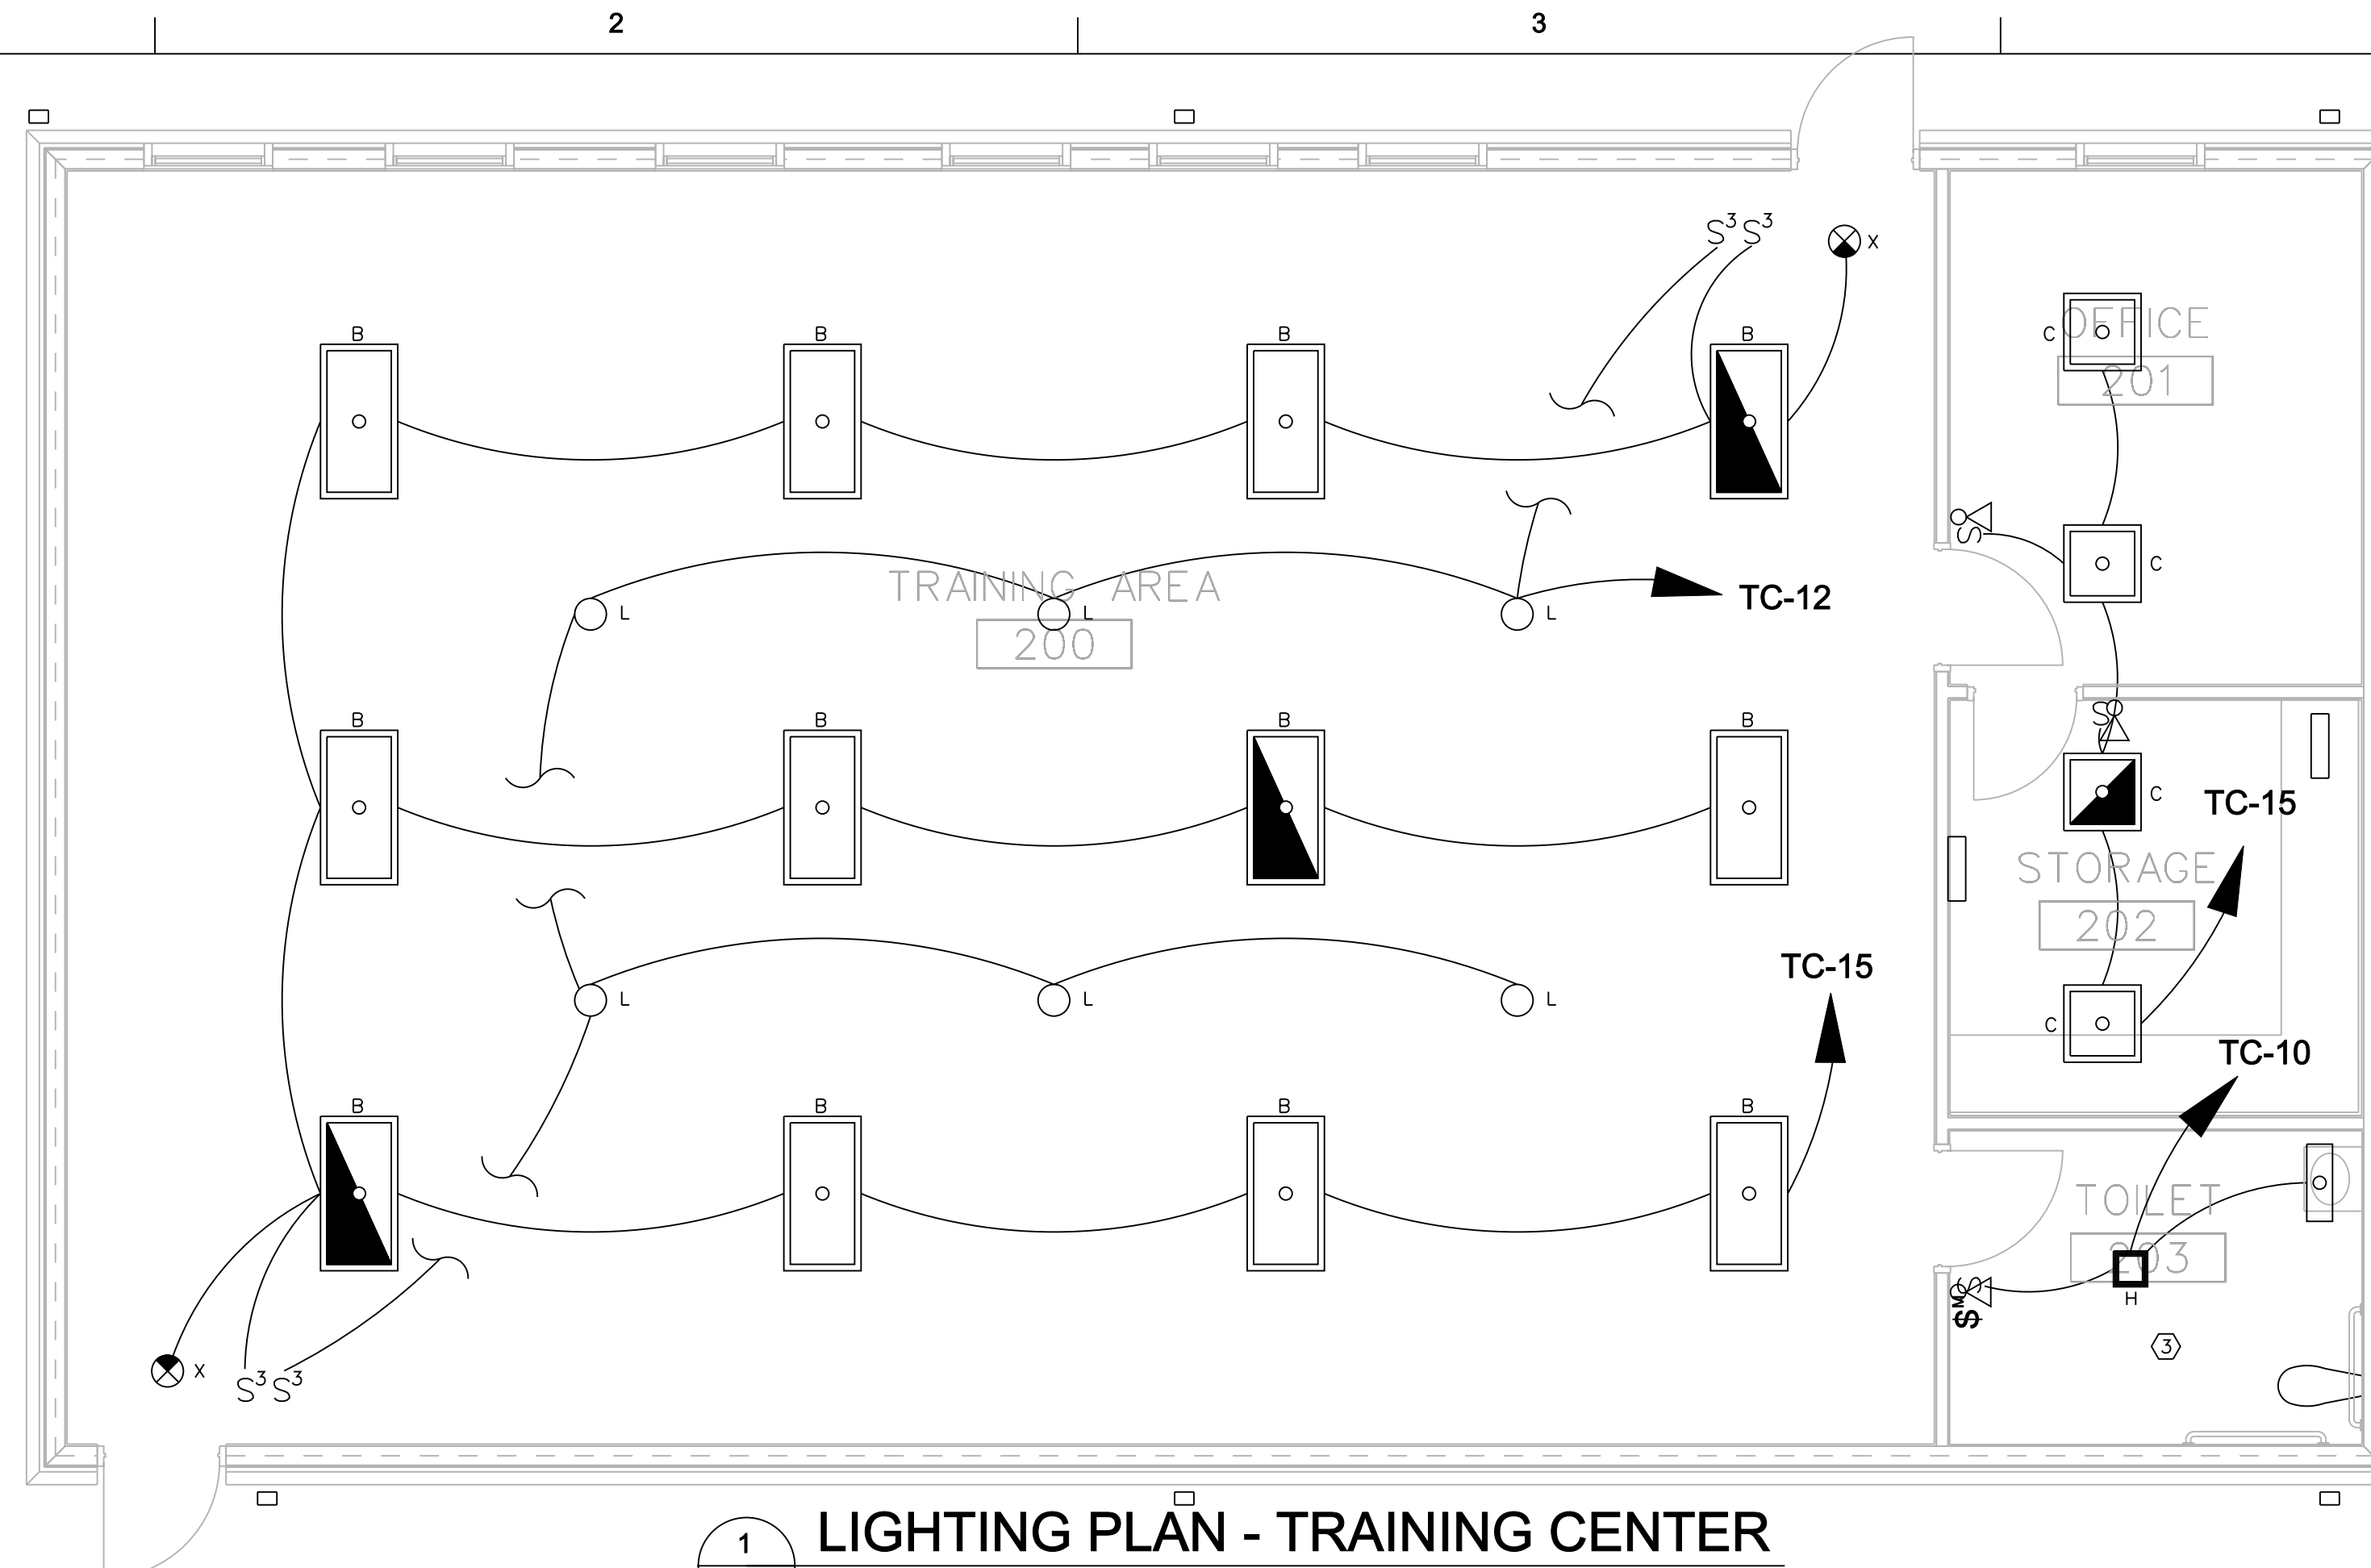

1 LIGHTING PLAN - TRAINING CENTER
SCALE: 1/4" = 1'-0"

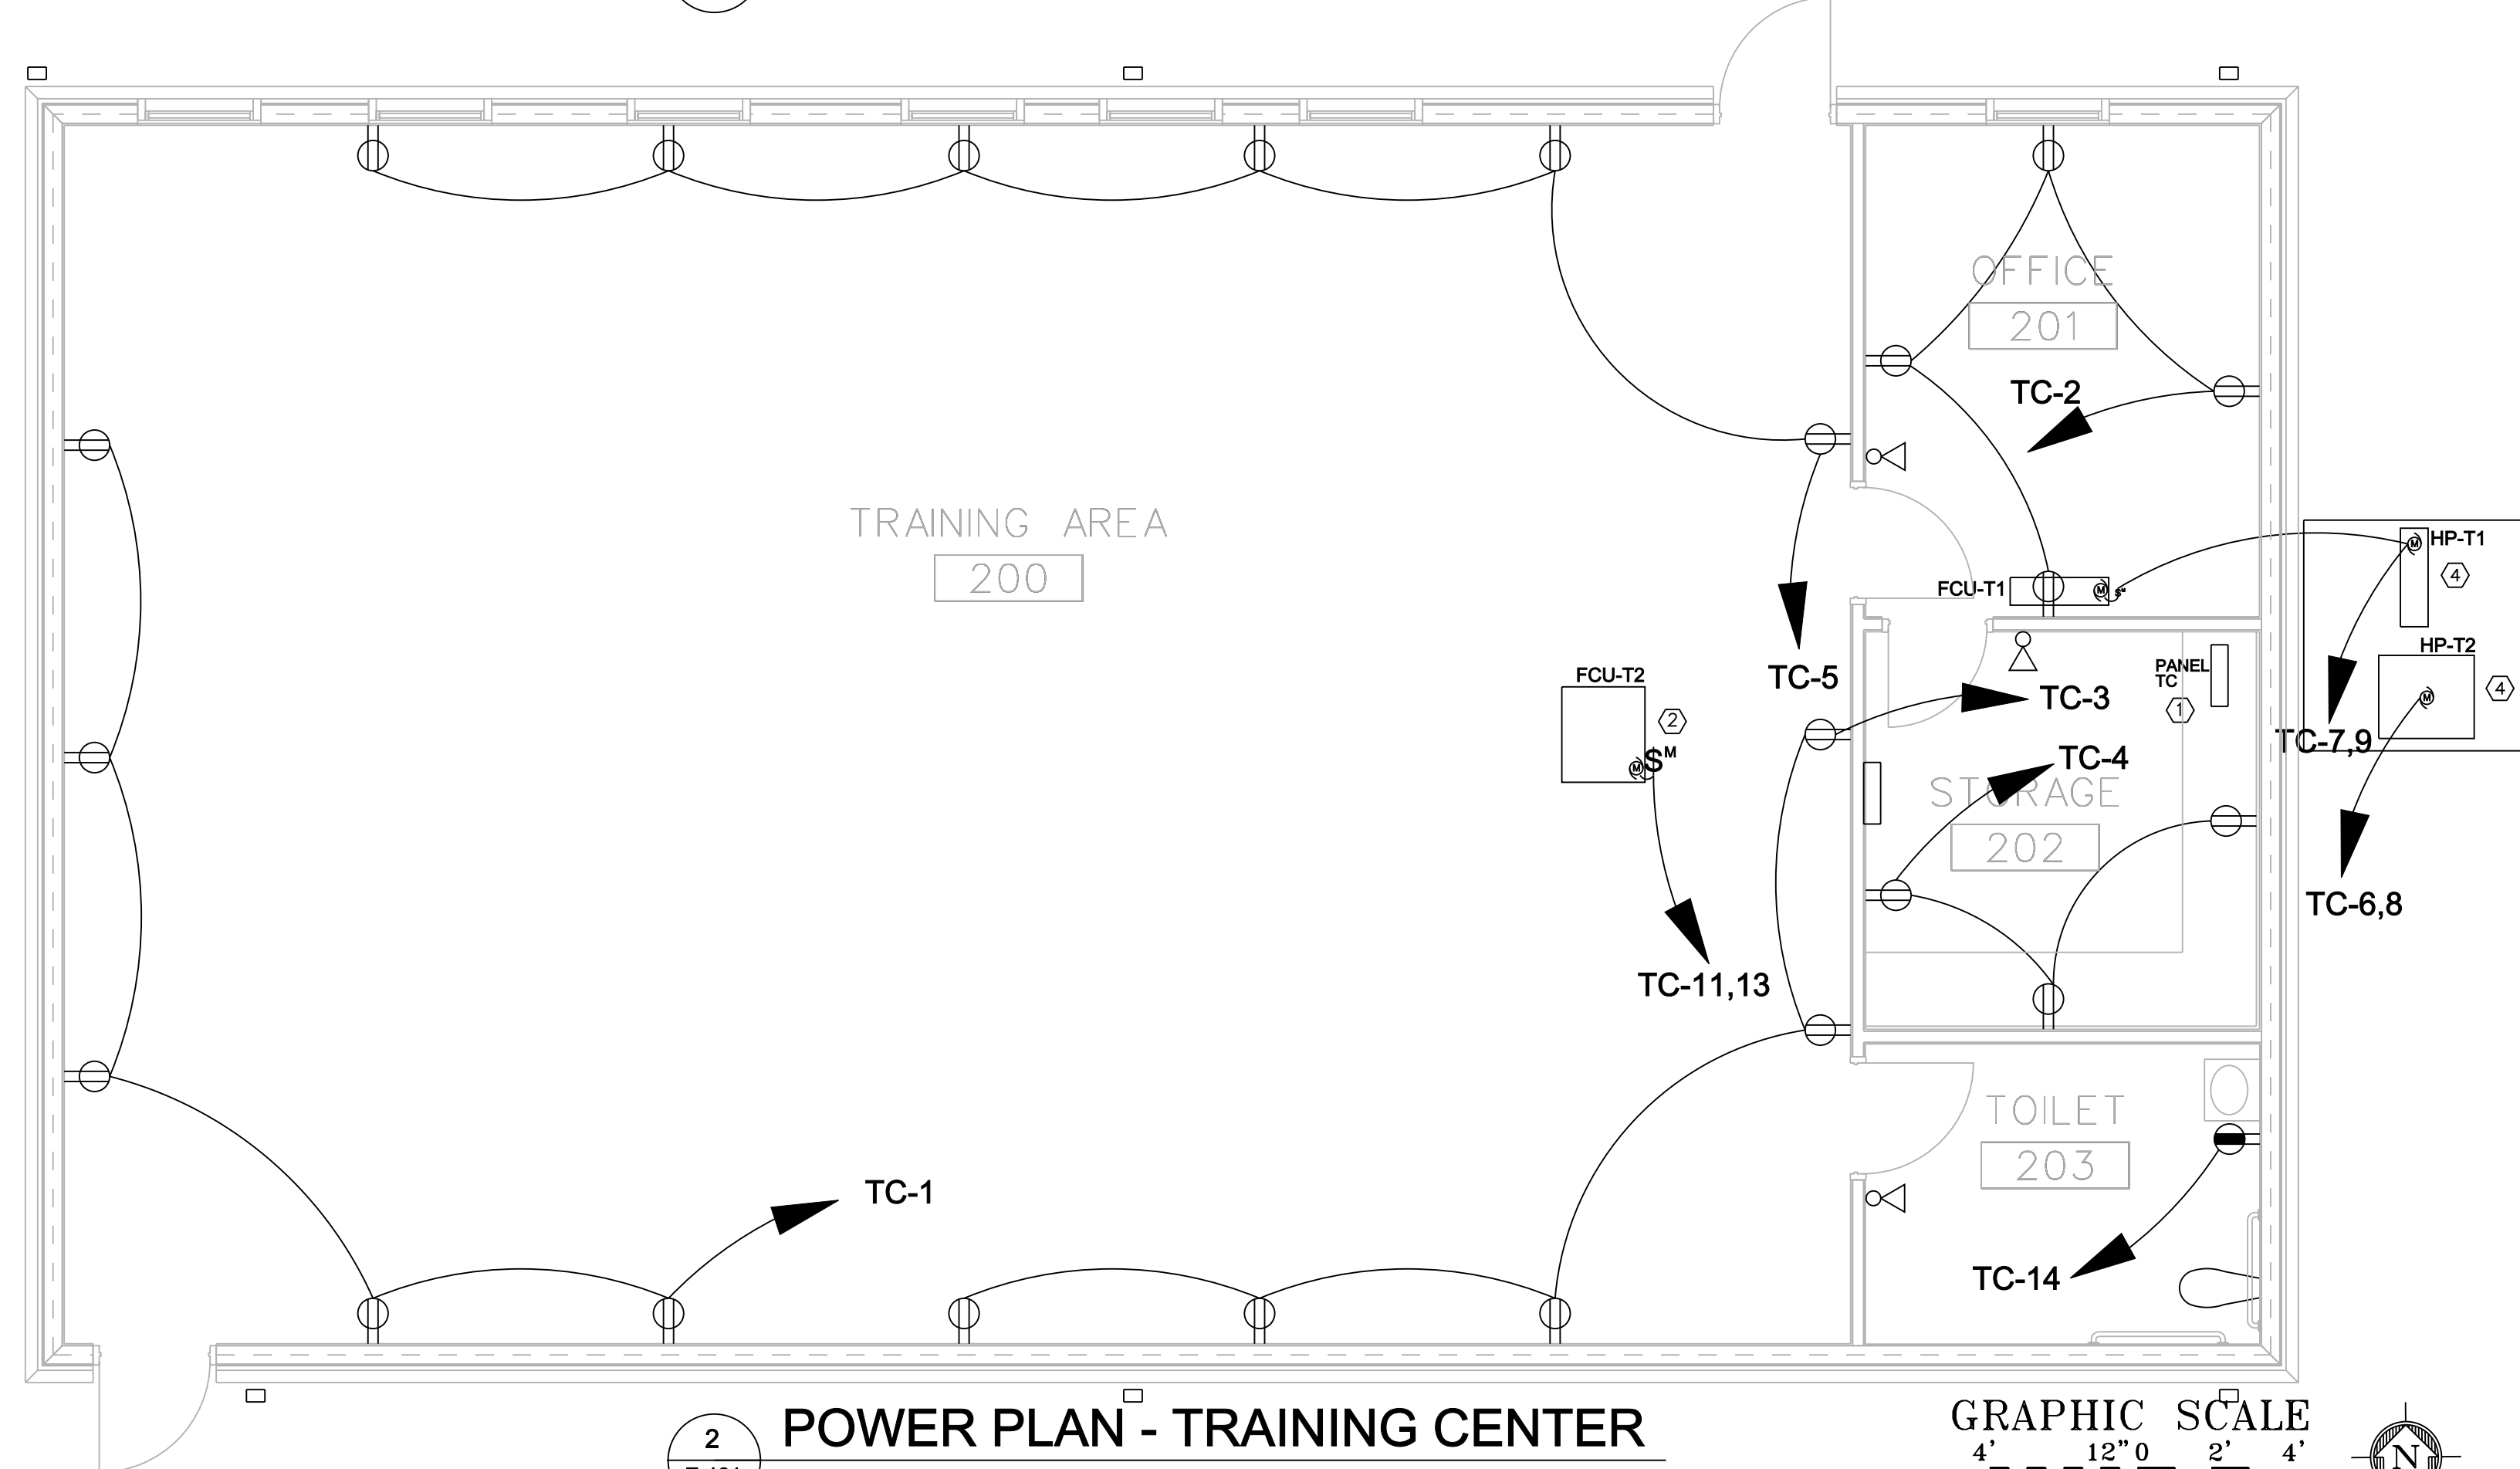

2 POWER PLAN - TRAINING CENTER
SCALE: 1/4" = 1'-0"

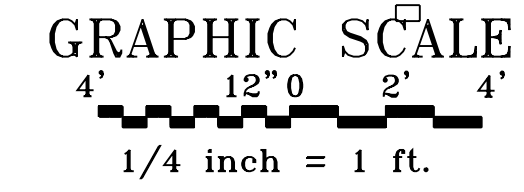


KCI Associates of North Carolina, PA
Engineers • Planners • Scientists • Construction Managers
4011 Six Forks Road, Lenoir Center II, Suite 220
Raleigh, NC 27609-5210
Phone (919) 782-9214
Fax (919) 782-9266
www.kci.com



STOA
Architects
121 EAST GOVERNMENT STREET
PENSACOLA, FL 32502 (850)432-1912

3 MARCH 2010 BUILDING DESIGN FINAL DESIGN FOR CONSTRUCTION

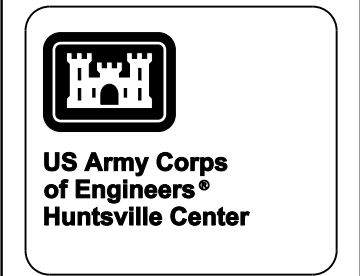

MARK	DESCRIPTION	DATE	APPR.
A	100% PRE-FINAL DESIGN	11/06/09	
B	FINAL DESIGN FOR CONSTRUCTION	03/03/10	

DESIGNED BY: SMH	CHKD BY: JDL	DATE: 26-JULY-2009
DWN BY: SMH	SUBMITTED BY: KOT	SOLICITATION NO.: W912DY09R0021
AS NOTED	FILE NAME: FS_SMT_01	CONTRACT NO.: W912DY09C003
SIZE: A3/D	FILE NUMBER: XXXXXX	FILE NO.: XXXXXX

U.S. ARMY CORPS OF ENGINEERS
HUNTSVILLE CENTER

15TH STREET FIRE STATION
FORT STEWART, GEORGIA

LIGHTING AND POWER PLAN - TRAINING CENTER

SHEET IDENTIFICATION
E-121
SHEET 111 OF 117

02:47 PM on Thursday, March 04, 2010
 M:\2009\12082908-FStewart\ENGR\BIM\Con_Doc\CAD_Sheets\Electrical\FS_E-121.dgn